



1. ALL EXPOSED WALL TILE EDGES MUST BE FINISHED TO MATCH TILE SURFACE. EASE TILE EDGES AS ALLOWABLE.
2. BLINDS SHALL BE PROVIDED BY OWNER AND INSTALLED BY VENDOR. COORDINATE WITH PANDA PROJECT MANAGER PRIOR TO INSTALLATION
3. PROVIDE 1/2" CLEAR PLASTIC CORNER GUARD FOR ALL INTERIOR PAINTED SURFACE W/ CLEAR GLUE.
4. ALL TILES INSTALLED NOT TO BE CUT LESS THAN 1/2 THE TILE WIDTH.
5. REFERENCE SHEET A-103 FOR WALL PANEL SCHEDULE
6. REFERENCE SHEET A-103 FOR SPECIAL SURFACE SCHEDULE
7. REFERENCE SHEET A-103 FOR INTERIOR PAINT SCHEDULE
8. REFERENCE SHEET A-104 FOR TILE SCHEDULE
9. REFERENCE SHEET A-104 FOR EXTENT OF COVE TRIM AT BASE

COORDINATE LOCATION OF ALARM DEVICES
WITH ARTWORK (IF REQUIRED).

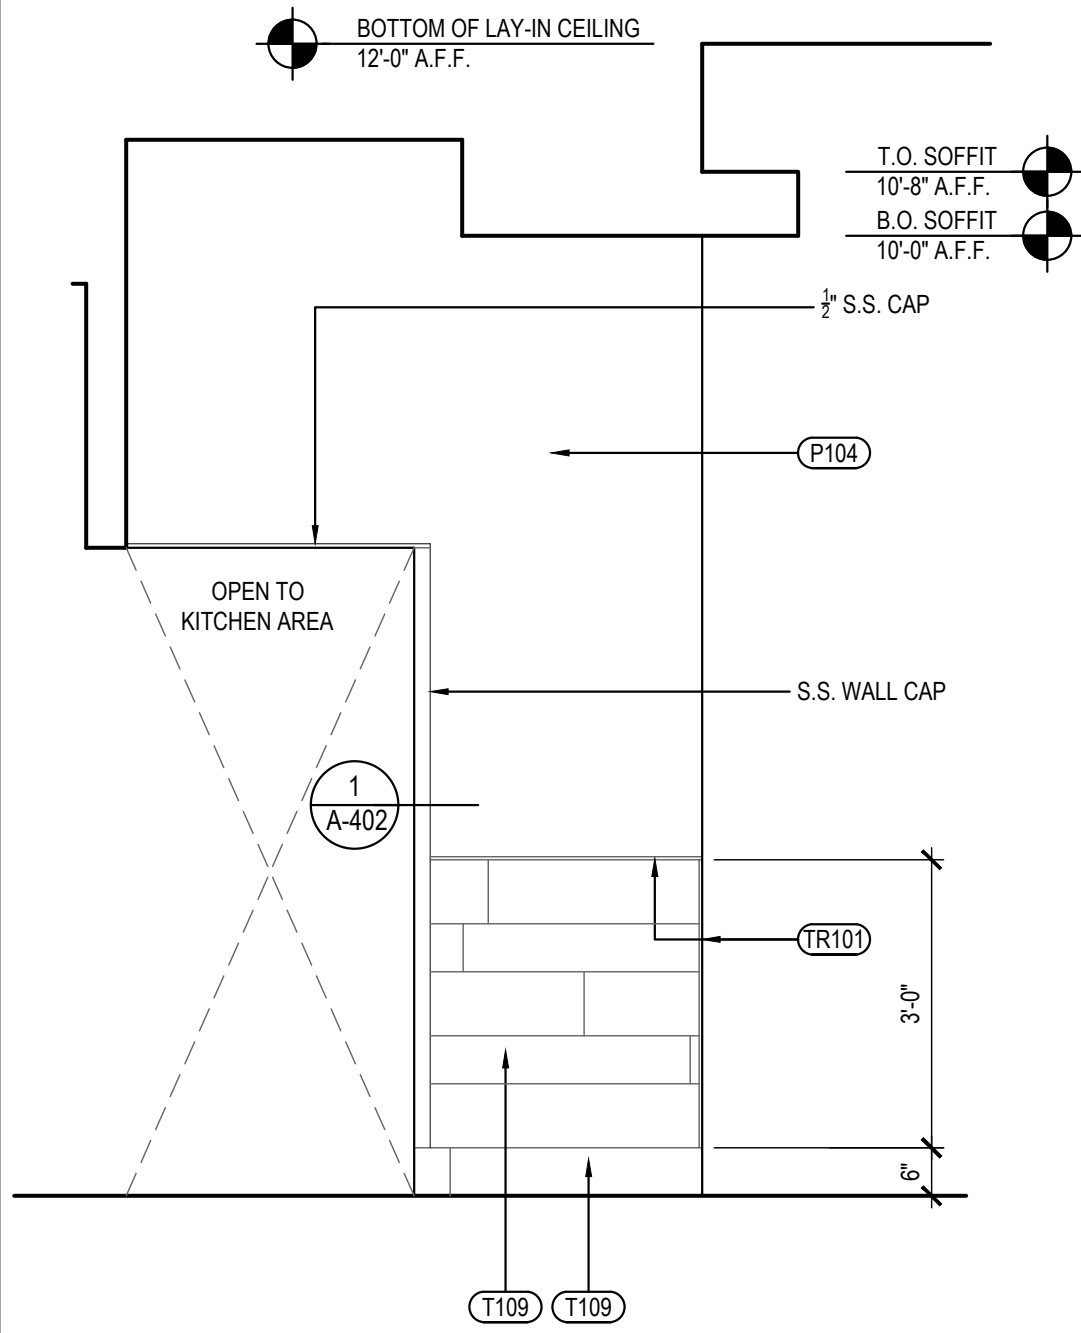


DINING ROOM ELEVATION	4
-----------------------	---

Scale= 1/2" = 1'-0" | A-500

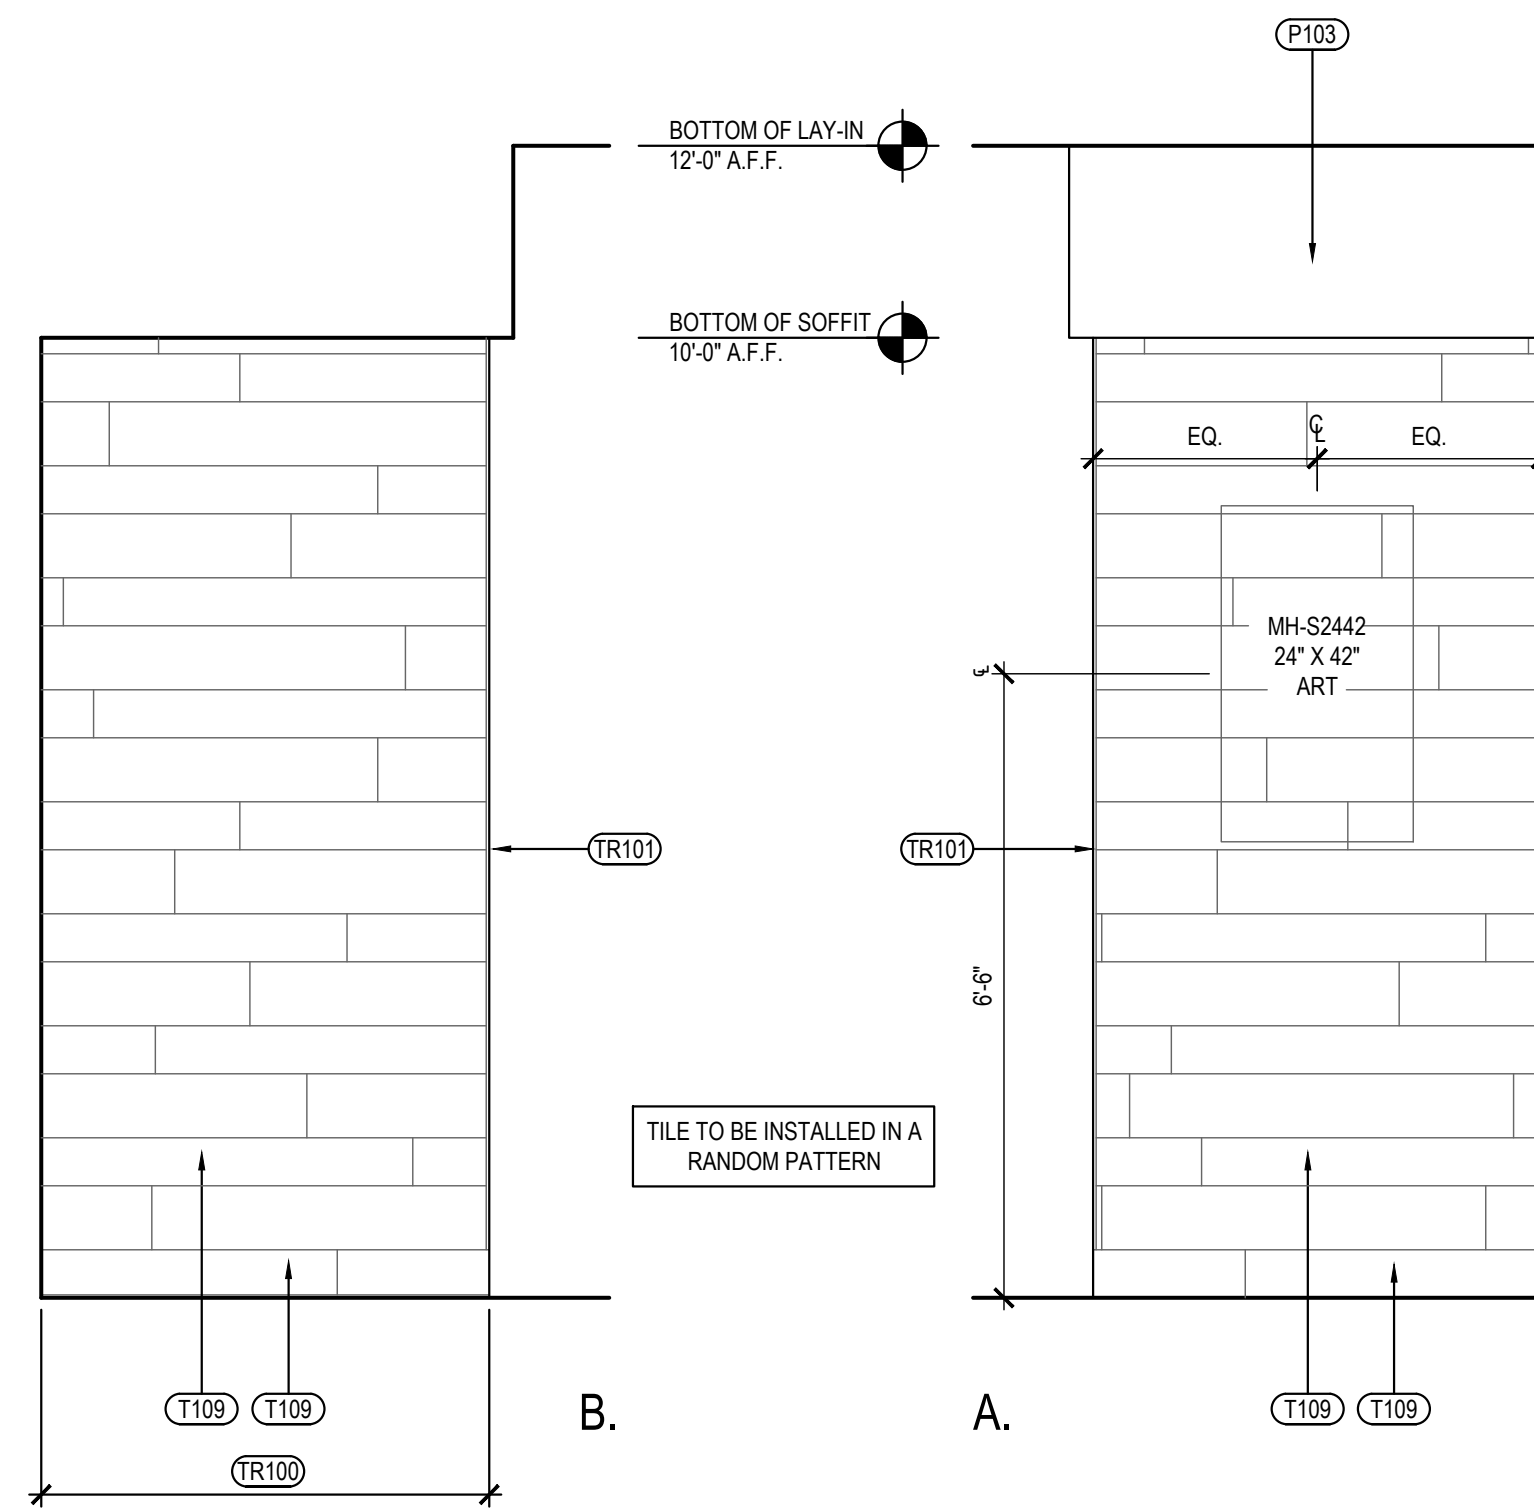


DINING ROOM ELEVATIONS BY DRINK STATION 3

Scale= 1/2" = 1'-0" | **A-500**

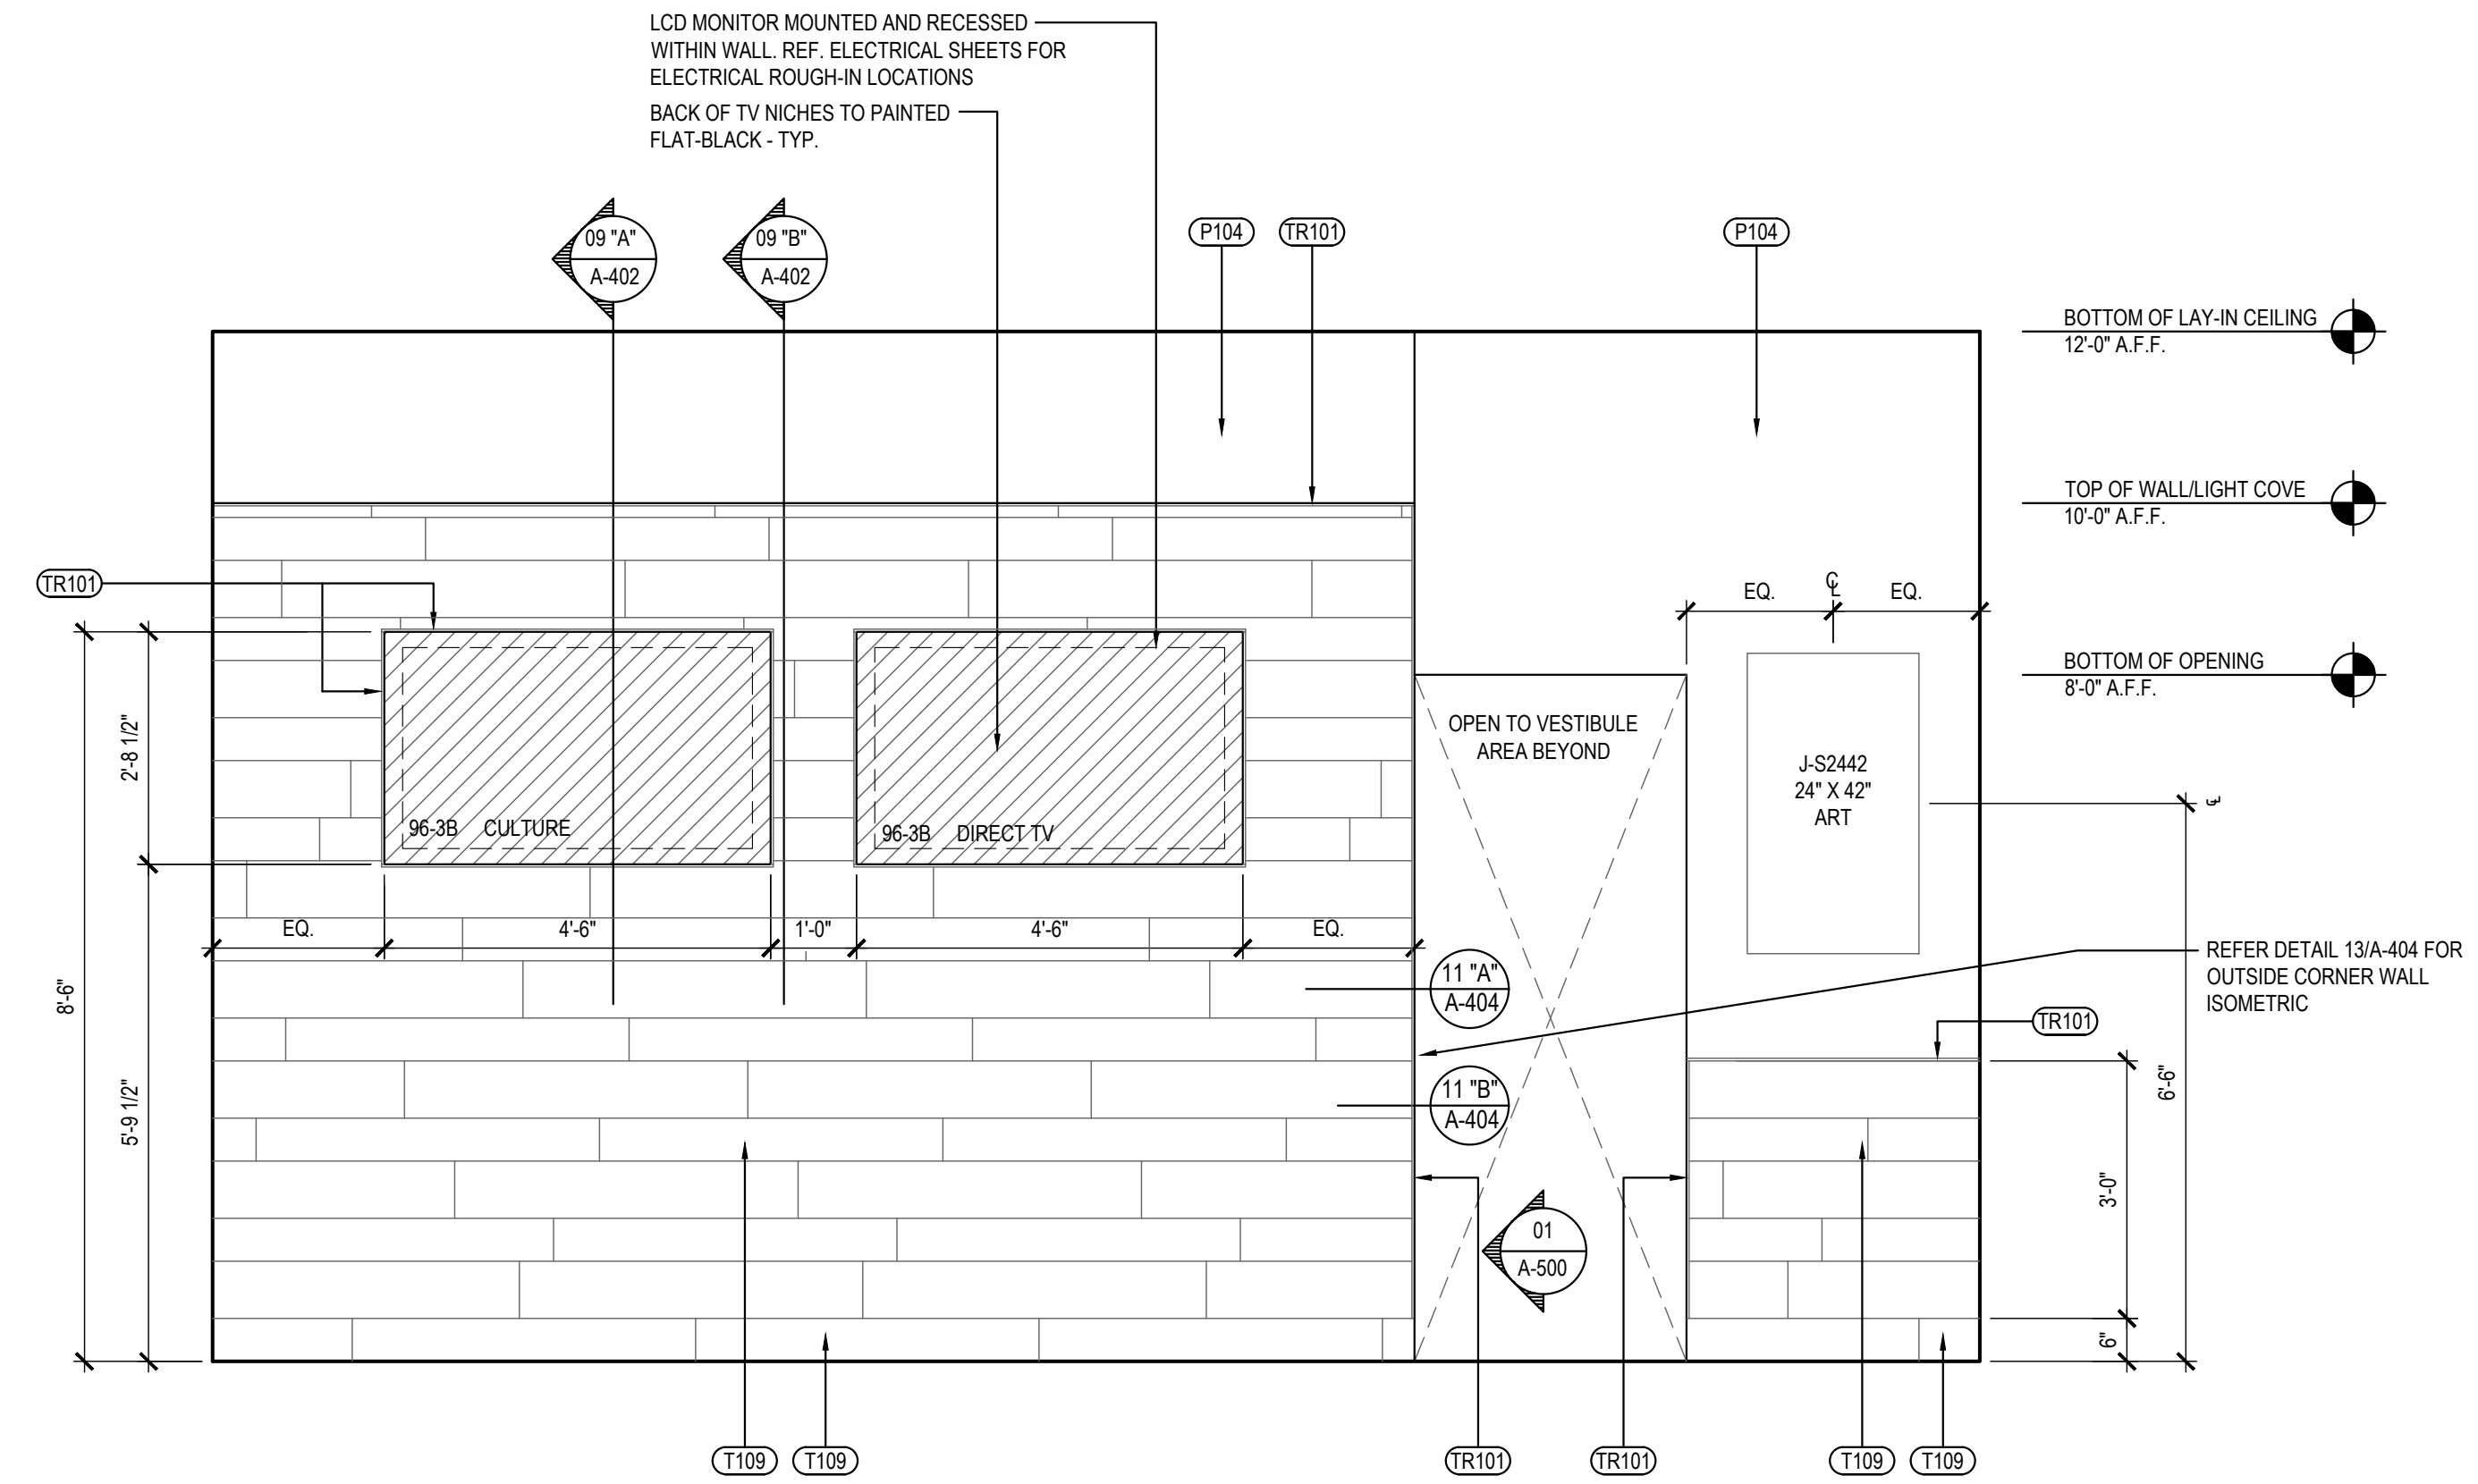


DINING ROOM ELEVATION 2

Scale= 1/2" = 1'-0" | **A-500**

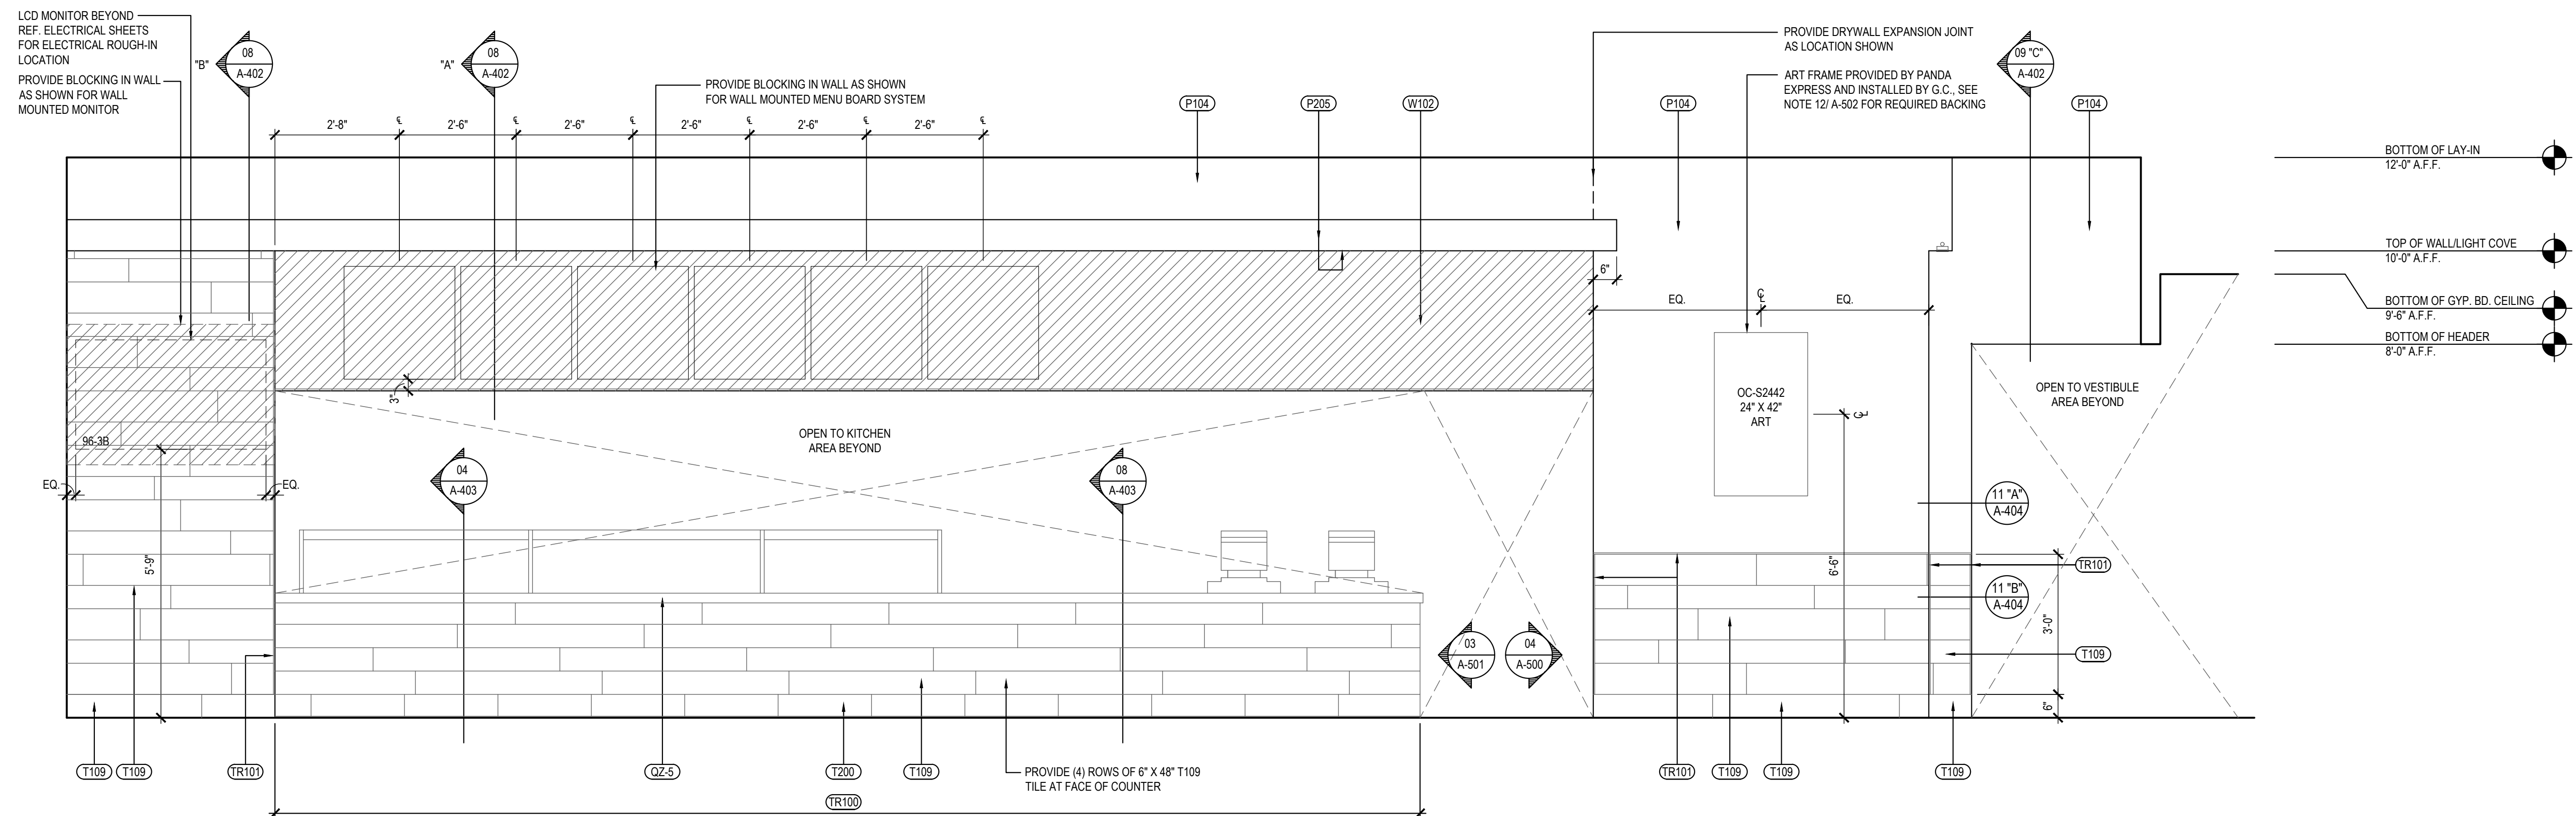

DINING ROOM ELEVATION	1
-----------------------	---

Scale= 1/2" = 1'-0"	A-500
---------------------	-------

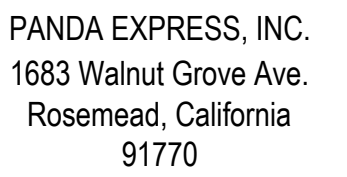

Telephone: 626.799.9898
Facsimile: 626.372.8288

All ideas, designs, arrangement and plans indicated or represented by this drawing are the property of Panda Express Inc. and were created for use on this specific project. None of these ideas, designs, arrangements or plans may be used by or disclosed to any person, firm, or corporation without the written permission of Panda Express Inc.

REVISIONS:

[illegible]


ISSUE DATE:

1st	PERMIT	12-22-17
2nd	BID	02-02-18

DRAWN BY: VTL

PANDA PROJECT #: S8-19-5806

 ARCH PROJECT #: 17044.032



PANDA EXPRESS

OLD LEE HWY & LITTLE DEBBIE PKWY
8967 OLD LEE HIGHWAY
COLLEGEDALE, TN 37363

A-500

INTERIOR ELEVATIONS

TRUE WARM & WELCOME 2200

BID SET 02.02.18